


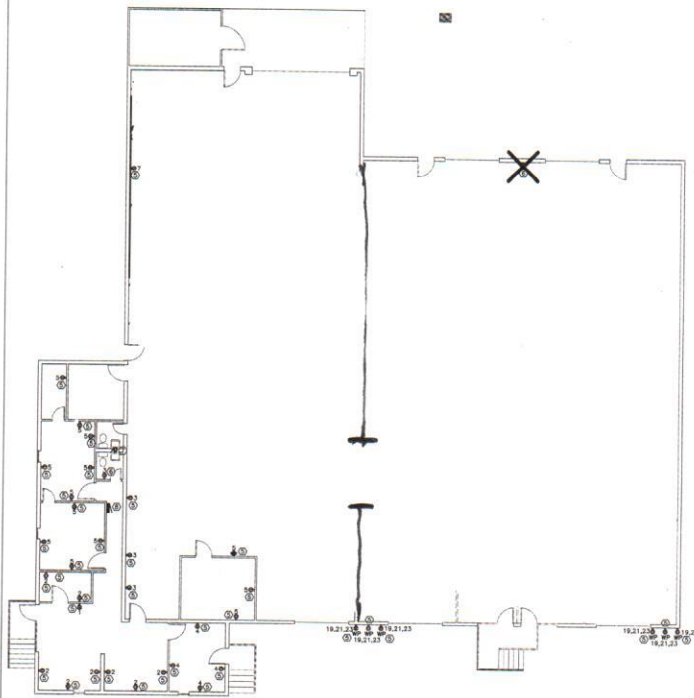

1 EXISTING POWER PLAN
E-2 SCALE: 1/8"=1'-0"

- KEY NOTES:
1. LOCATION OF EXISTING 150KVA 120/208V 34 CIR TRANSFORMER.
 2. LOCATION OF EXISTING CSU METER TO REMAIN.
 3. EXISTING ELECTRICAL PANEL TO REMAIN. PROVIDE NEW BREAKERS AS NEEDED. ELECTRICAL CONTRACTOR TO FIELD VERIFY.
 4. NEW ELECTRICAL PANEL TO BE INSTALLED UNDER THIS SCOPE OF WORK.
 5. EXISTING RECEPTACLE TO REMAIN.
 6. EXISTING RECEPTACLE TO BE DEMOLISHED.
 7. EXISTING CONNECTION TO WATER HEATER TO REMAIN.
 8. LOCATION OF EXISTING ELECTRICAL PANEL TO BE REMOVED AND RELOCATED.
 9. NEW LOCATION OF EXISTING PANEL TO BE REINSTALLED.
 10. EXISTING DISCONNECT TO BE DEMOLISHED.
 11. ALL OTHER ELECTRICAL IN THIS AREA IS EXISTING TO REMAIN.

- KEY NOTES:
1. ELECTRICAL CONTRACTOR TO VERIFY ALL EXISTING AND REQUIRED CIRCUIT.
 2. ALL OTHER ELECTRICAL WORK NOT SHOWN IN PLAN IS EXISTING TO REMAIN.



MCM ENGINEERING
MECHANICAL ELECTRICAL MECHANICAL
 3885 VAN TETLENBERG, SUITE G
 7901 S. W. 14TH AVE.
 COLORADO SPRINGS, CO 80911
 MCMENGINEERING.COM

DURANGO SHOP
 2885 DURANGO DRIVE
 COLORADO SPRINGS, CO 80910

ELECTRICAL POWER PLAN
 E-2
 SHEET NUMBER

DATE: 10/1/2019
 DESIGNED BY: EAC
 CHECKED BY: JMC
 DRAWING FILE NAME:

REVISIONS